

1 Level 1  
3/16" = 1'-0"

Window Schedule			
Count	Family	Height	Level
4	Transom with Trim	2'-0"	Level 1


Door Schedule			
Count	Family	Height	Level
6	Door-Curtain-Wall-Single-Glass	7'-10 3/4"	Level 1
1	Door-Passage-Uneven-Flush	6'-8"	Level 1
2	Sectional OH Door With Dock Leveler_ amp Dock Shelter_14748	10'-0"	Level 1
9	Single-Flush		

DEVELOPMENT INFORMATION:  
 DRAWING TITLE: Floor Plan  
 SCALE: 3/16" = 1'-0"  
 DESIGNED BY: CADS25  
 SHEET NO: A-2

Keynote Legend	
Key Value	Keynote Text
12.13	Sofa
22.02	Wall-Mounted Vitreous Lavatory
22.03	Commercial HC Toilet
22.05	Toilet Stall
22.06	Aided ADA Toilet Stall
22.07	Sink
22.08	Drinking Fountain
22.09	Water Heater
26.01	LG LED Inverted Sconce 35 Watts

Keynote Legend	
Key Value	Keynote Text
10.10	Checkout Counter
10.11	RFID Self-Checkout
10.12	Interior Signage
11.11	Pallet Jack
12.01	Chair
12.04	Circle Table w/ Chairs
12.07	Desk
12.08	Filling Cabinet
12.10	Fridge
12.11	Upper Cabinets
12.12	Counter w/ Base Cabinets

Keynote Legend	
Key Value	Keynote Text
05.01	Sectional Rolling Dock Door
06.02	Single-Flush 36" x 84" Door
06.03	Interior Plumbing Wall
06.04	Interior Wall
06.06	Single-Flush 30" x 80" Door
06.07	Uneven-Flush 54" x 80" Door
06.08	Curtain Wall Door
06.09	Curtain Wall
06.10	ICF Wall with R-18 Insulation
08.01	Transom with Trim 72" x 24"
10.09	Gondola

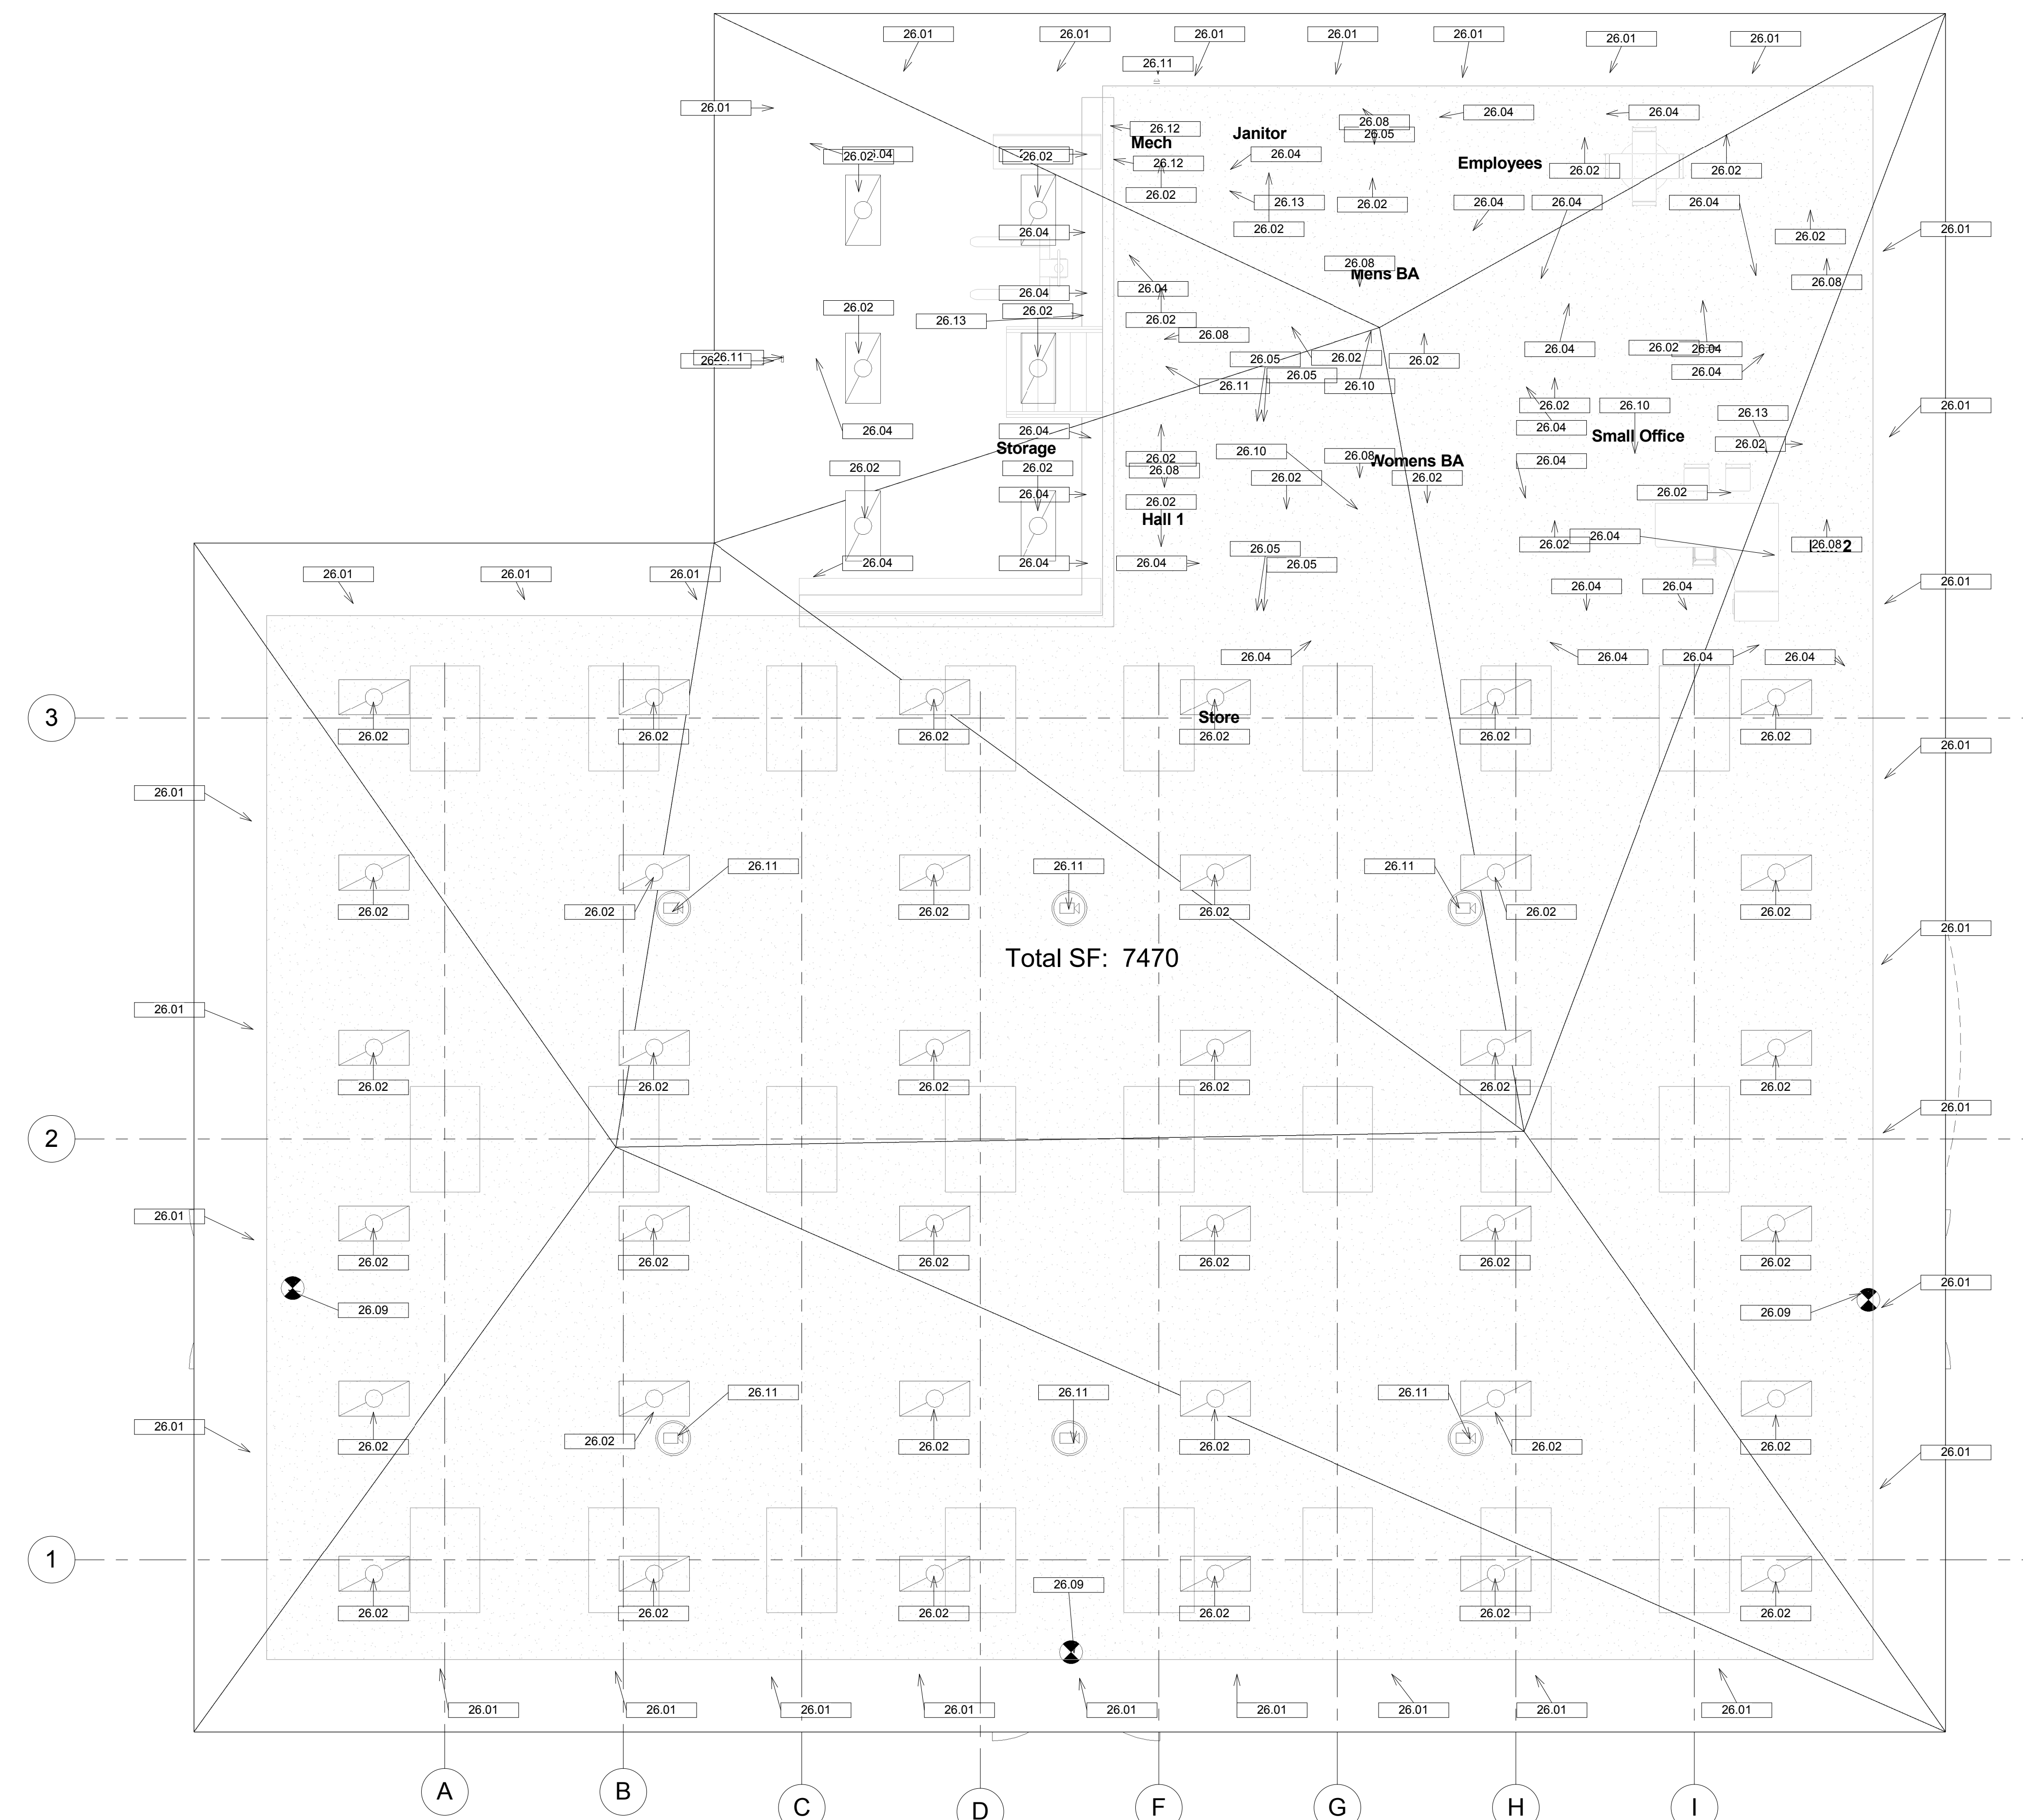

### Electrical Legend


- Floor Outlet - Duplex
- Outlet - Duplex
- Outlet GFI - Single
- Outlet GFI - Single Waterproof
- Switch - Dimmer
- Ceiling Occupancy Sensor - Low Voltage
- LG - Inverted Sconce
- Nicor 38 Watt LED Troffer
- Fire Exit Sign
- Smoke Detector
- Samsung Security Camera

Electrical Legend  
 1/4" = 1'-0"


### Keynote Legend

Key Value	Keynote Text
26.01	LG LED Inverted Sconce 35 Watts
26.02	Nicor 38 Watt 2x4 Troffer
26.04	Outlet - Duplex
26.05	Outlet GFI - Single
26.08	Ceiling Occupancy Sensor - Low Wattage
26.09	Emergency Exit Signage
26.10	Smoke Detector
26.11	Samsung Security Camera
26.12	Lighting and Appliance Panelboard
26.13	Switch

**1** Z Electrical Plan  
 3/16" = 1'-0"

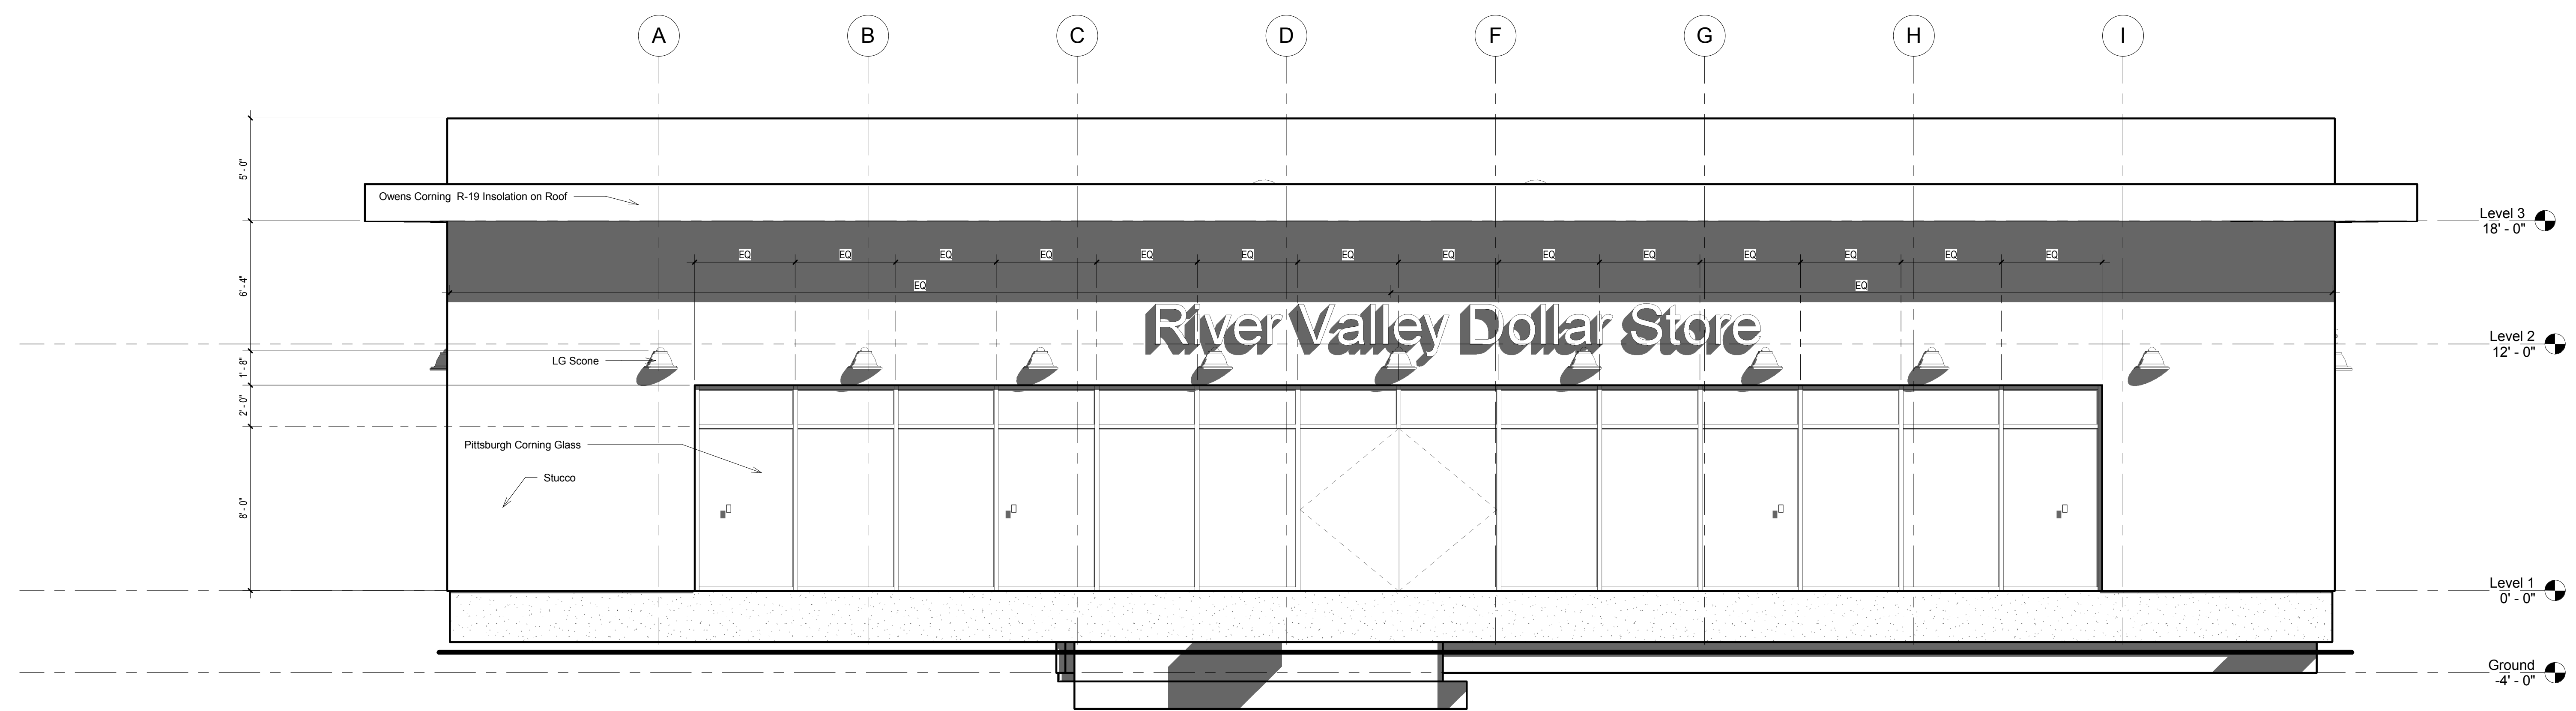


① Front  
 1/4" = 1'-0"

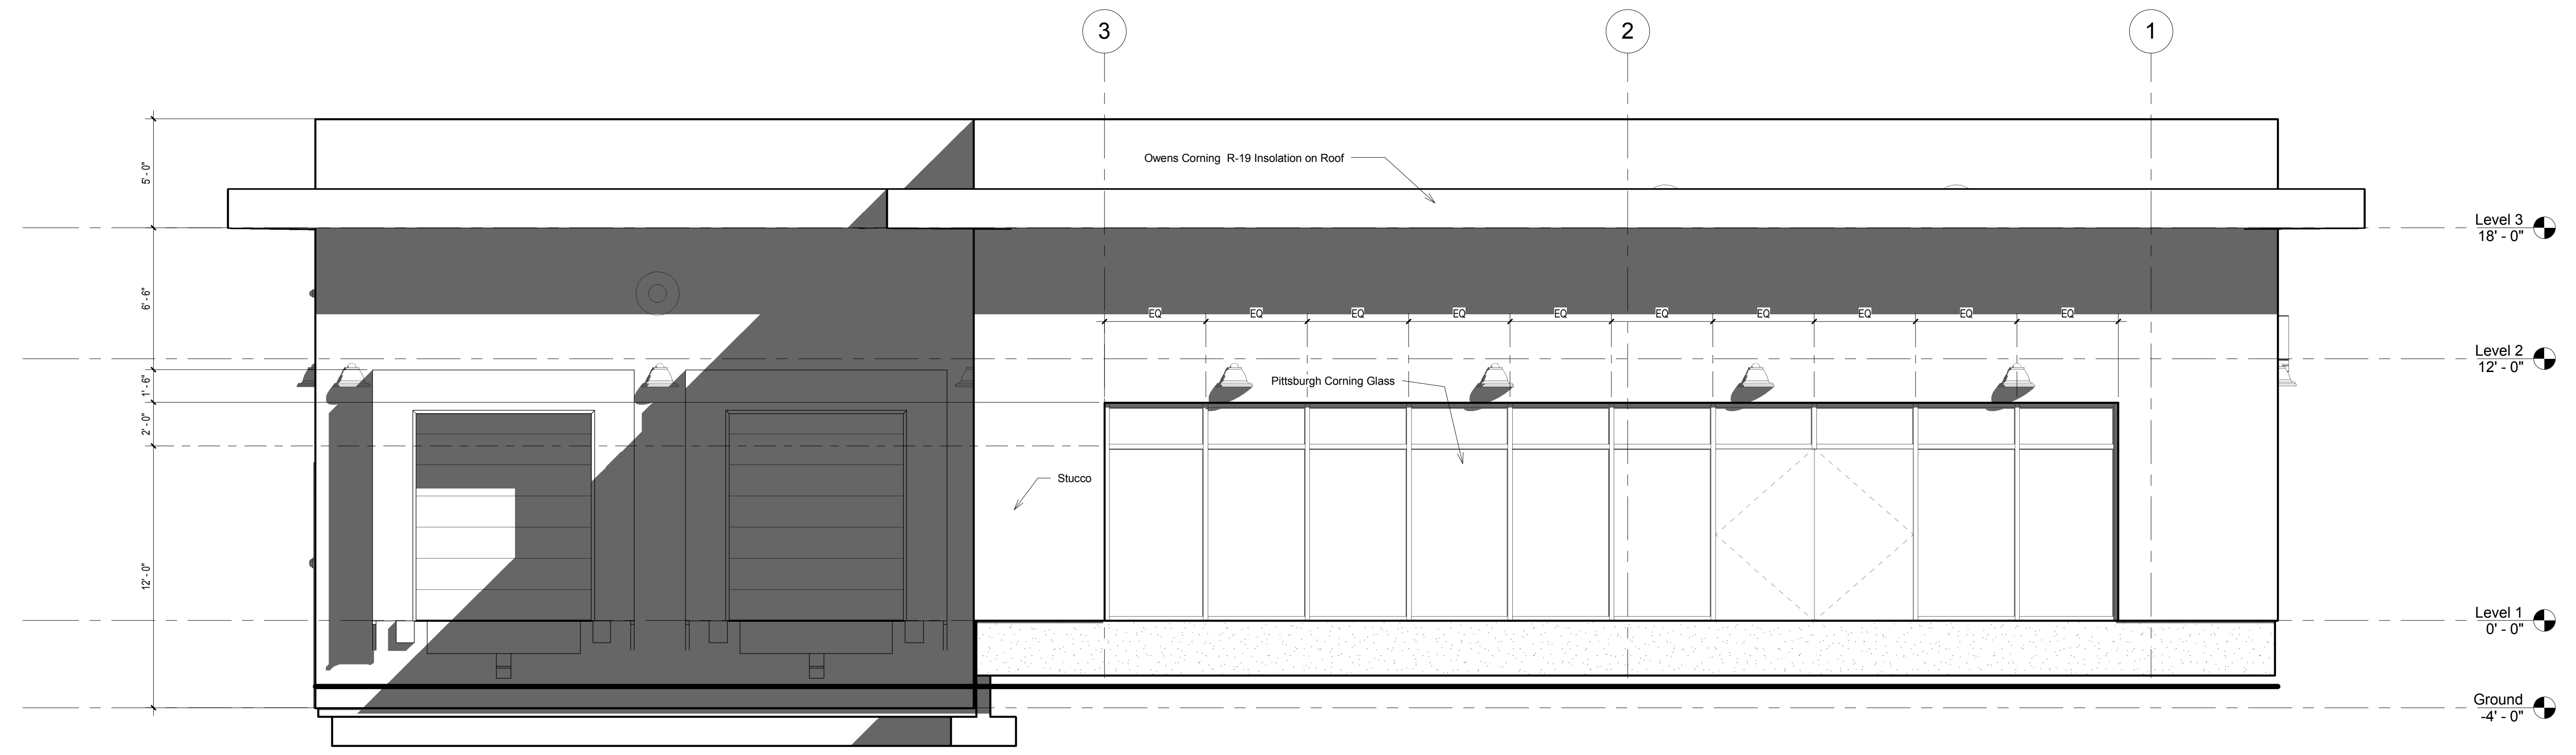

② Left  
 1/4" = 1'-0"



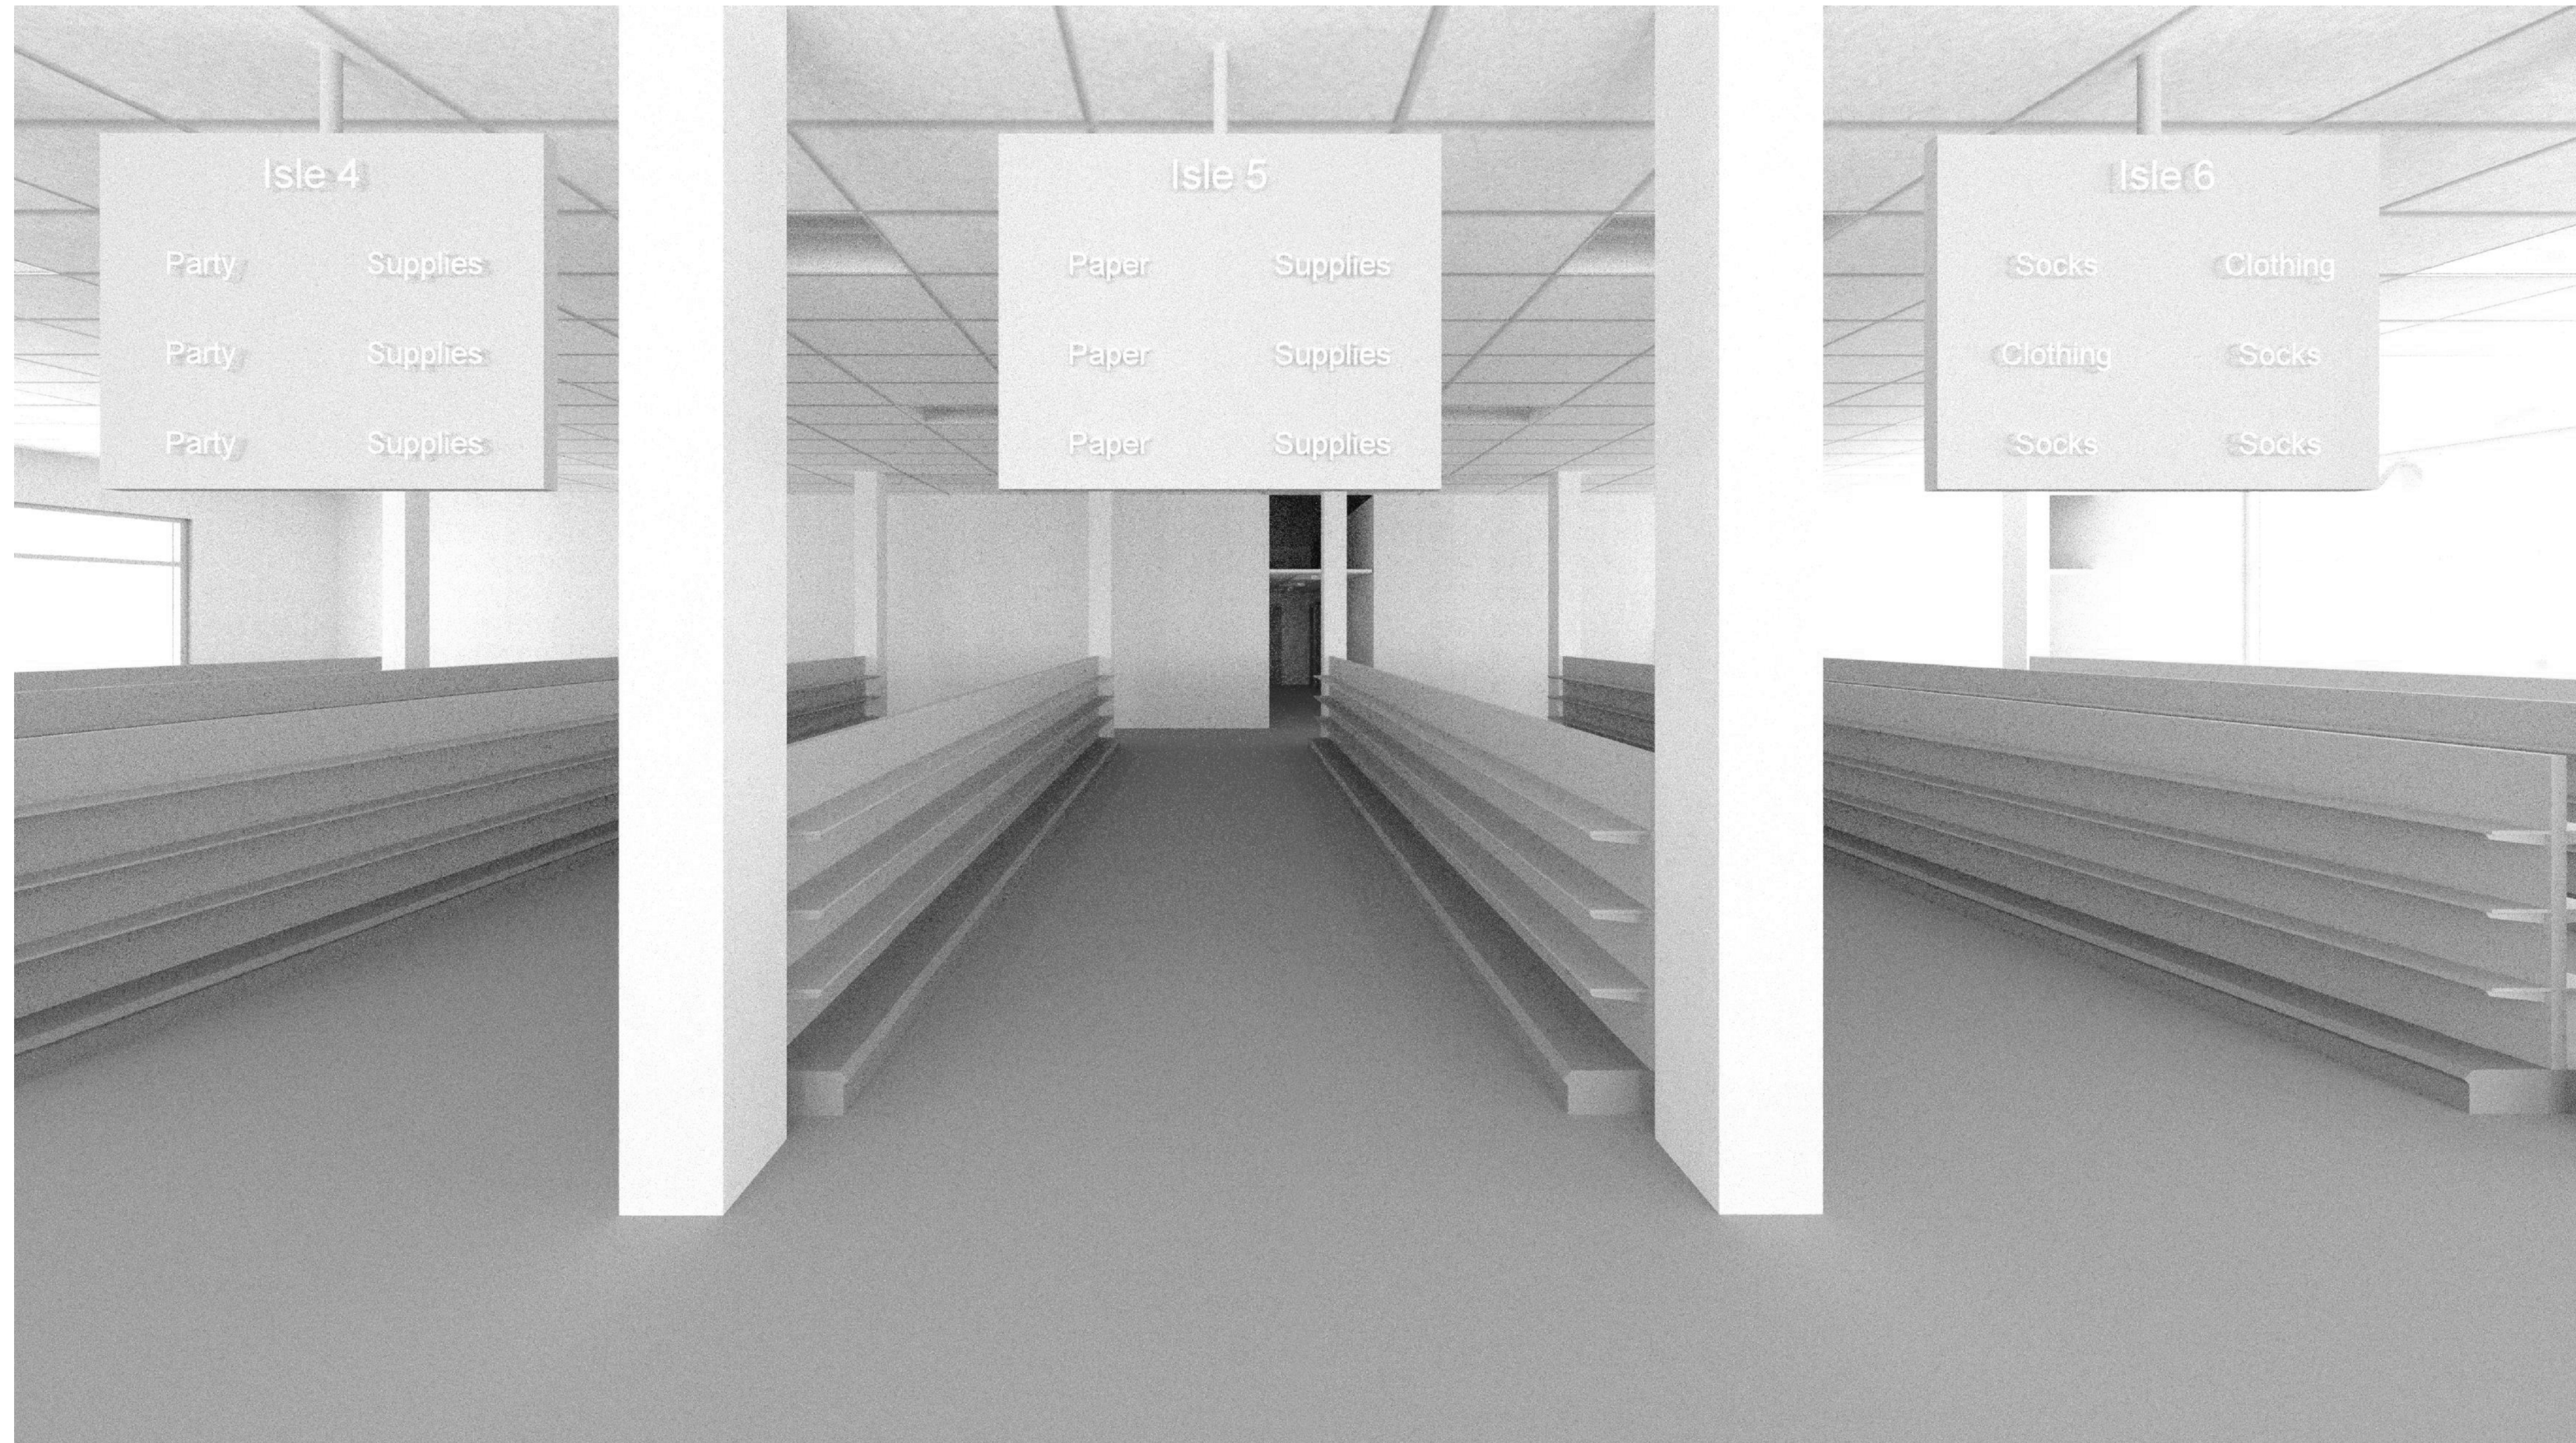


1 Interior Store View  
1/2" = 1'-0"



3 Interior Employee Room View  
1/2" = 1'-0"




2 Interior Office  
1 1/2" = 1'-0"

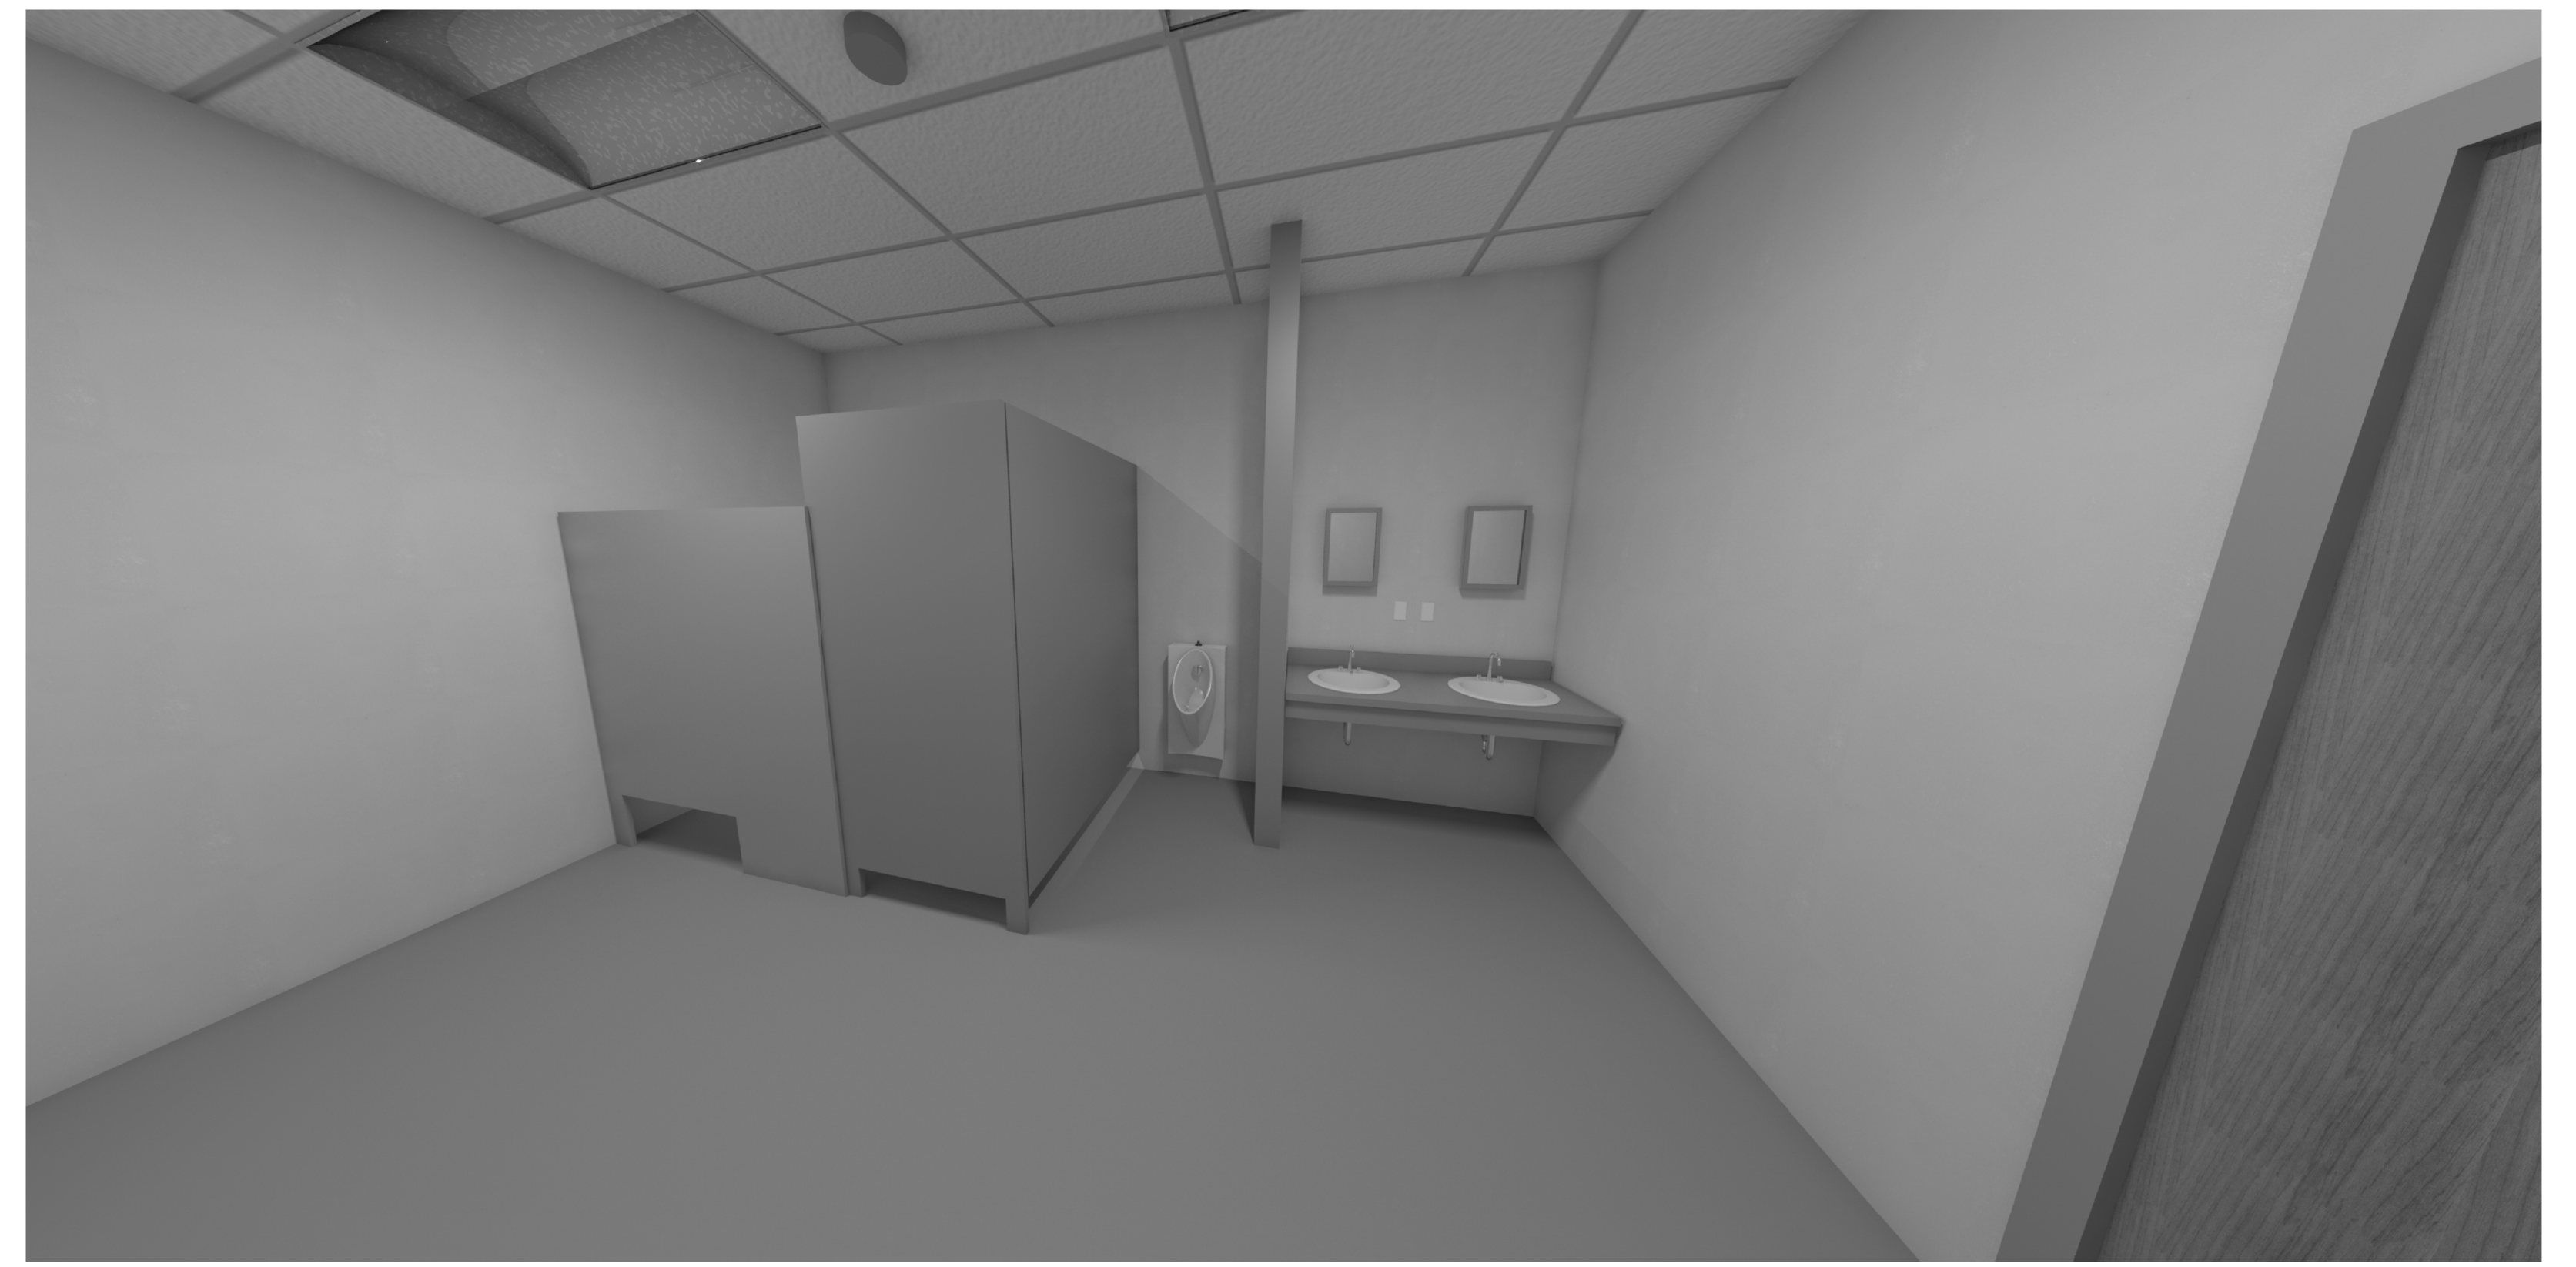

4 Interior View Bathroom  
3/4" = 1'-0"



① Exterior Front, Right  
1 1/2" = 1'-0"

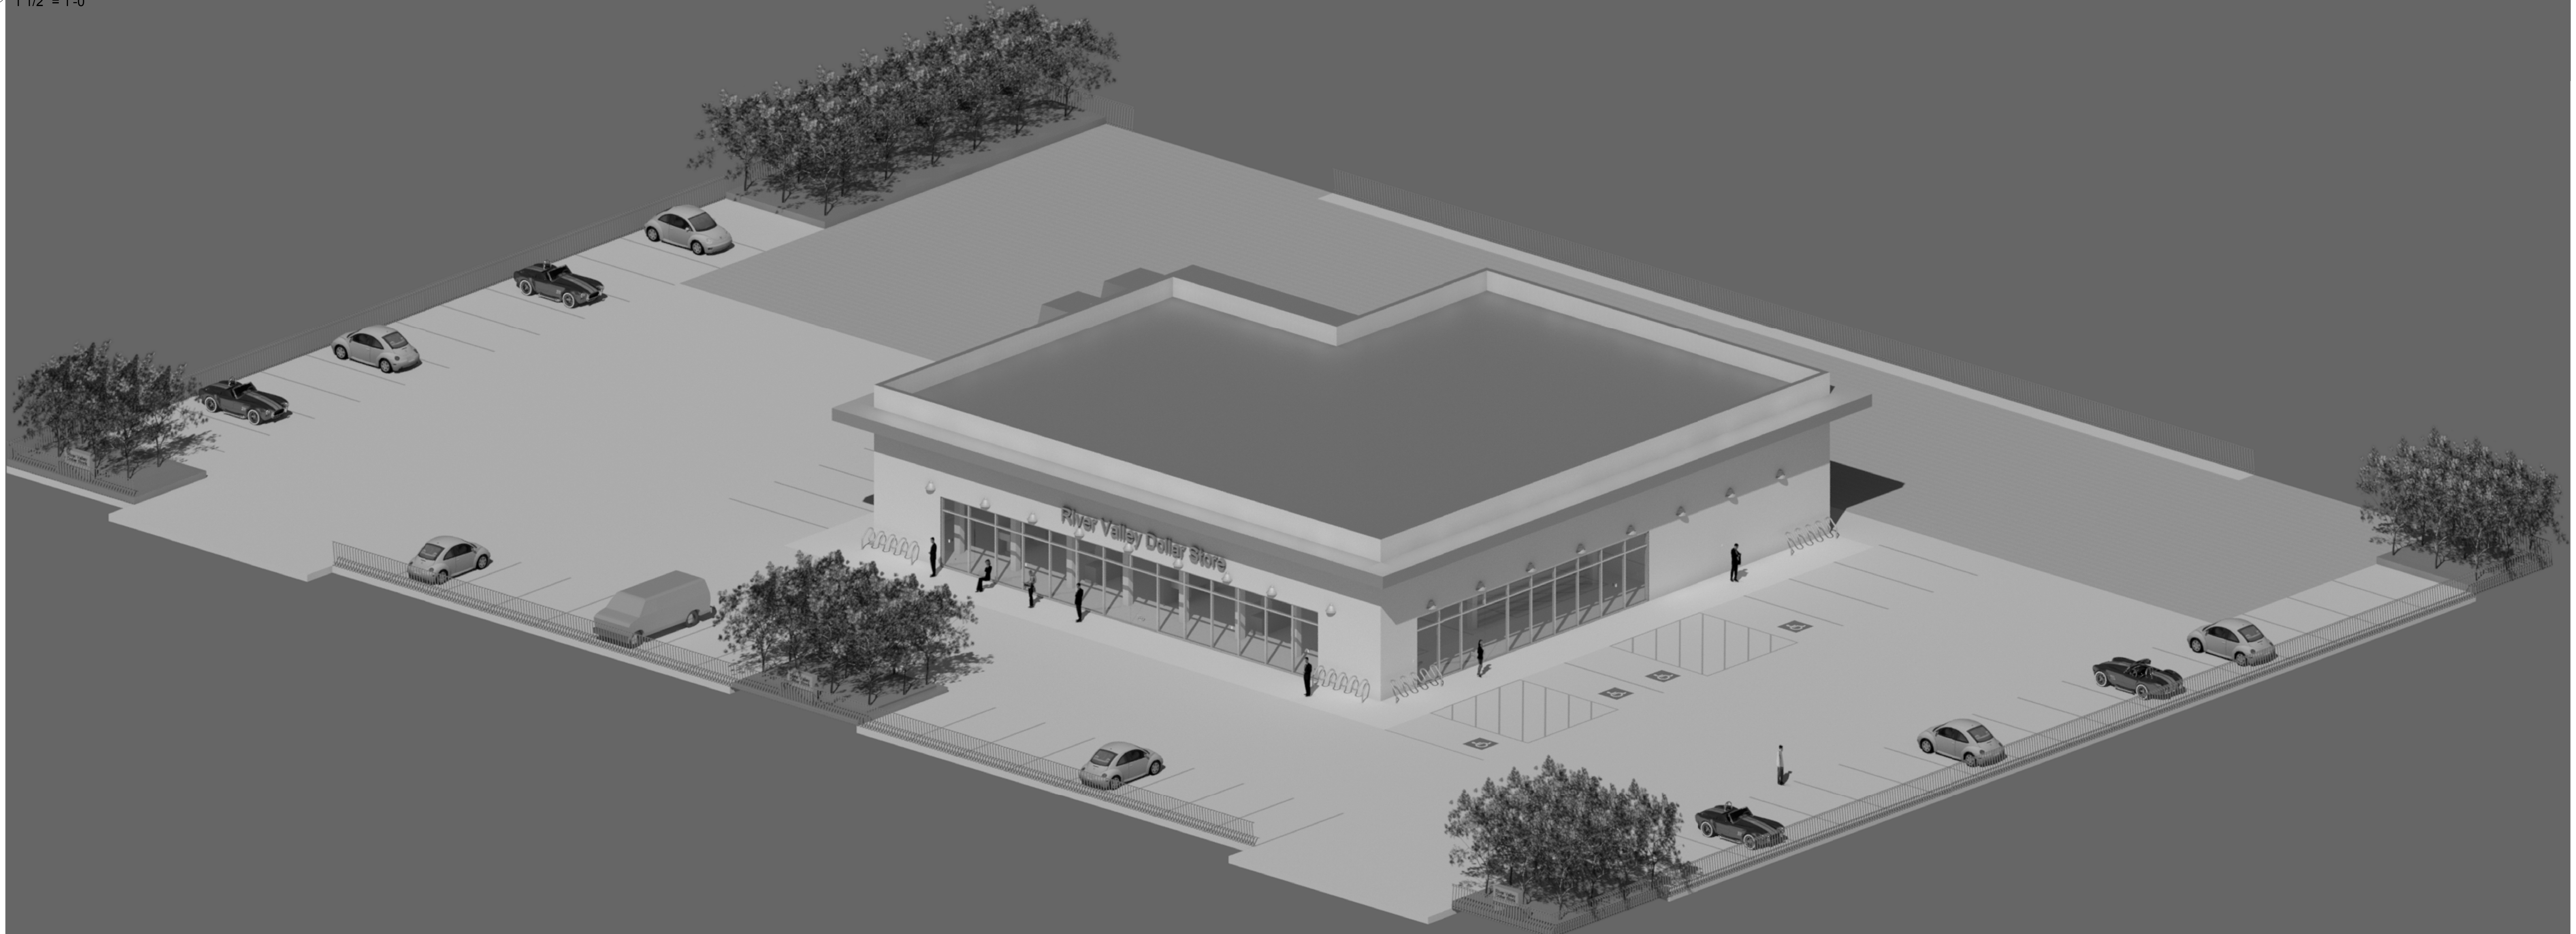

② Site  
1 1/2" = 1'-0"